


本图版权归为中国寰球工程公司所有，未经本公司许可不得复制或传播。 This diagram is the intellectual property of China Huanguo Contracting & Engineering Co., Ltd. No reproduction or distribution is permitted without the company's written consent.

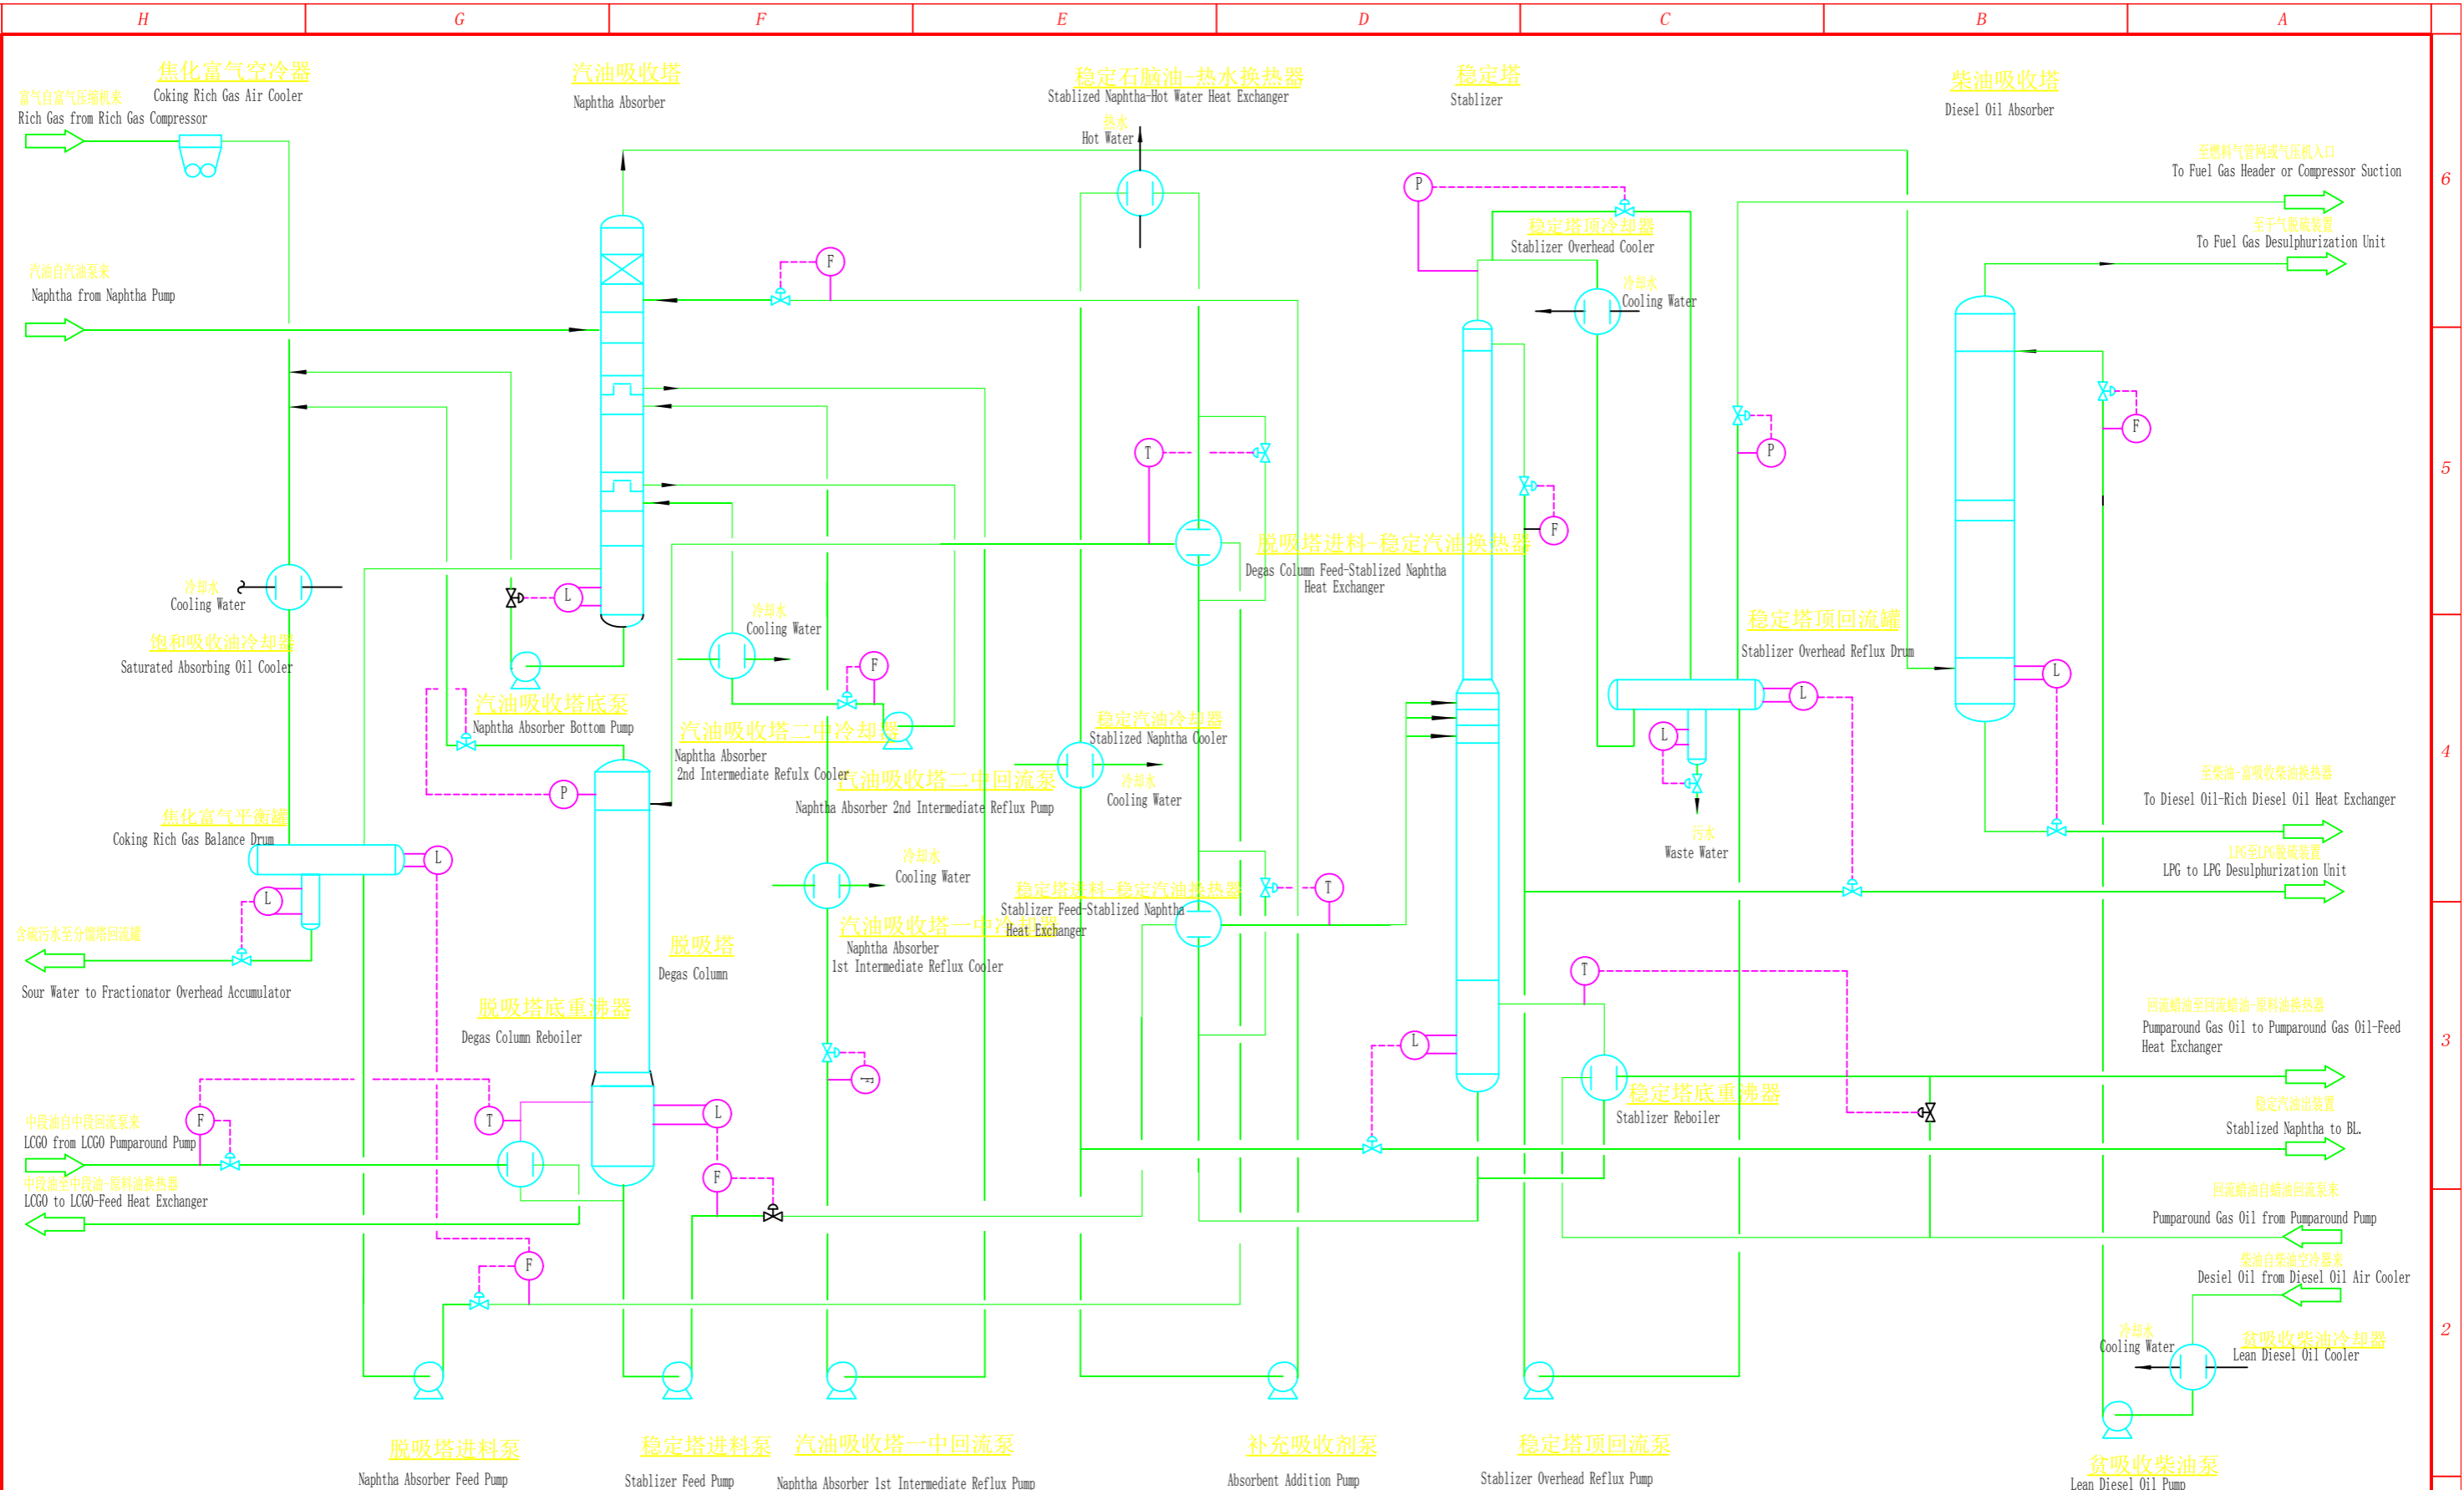

FO 2010.11.25 可行性研究 FEASIBILITY STUDY						
版次 REV	日期 DATE	说明 DESCRIPTION	设计 WORK	校核 CD	审核 DISC APP.	审定 APPR.
中国寰球工程公司 CHINA HUANGUO CONTRACTING & ENGINEERING COMP.			图名 TITLE 延迟焦化工艺流程图六 DELAYED COKING PROCESS FLOW DIAGRAM 6			
工程设计综合资质甲级 COMPREHENSIVE DESIGN LICENSE			证书编号 CERTIFICATE NO. A11101011			
项目 PROJ 哥斯达黎加MOIN炼油厂改扩建项目 COSTA RICA MOIN REFINERY REVAMP PROJECT			装置/工区 UNIT WORK AREA 延迟焦化装置 DELAYED COKING UNIT			
专业 SPECL 工艺 PROCESS		比例 SCALE 第 1 套共 1 套 OF		图号 DRAWING NO. 4.6-6		